


COMPANY - FOR GFC. WORK ONLY - TO BE RETURNED UPON REQUEST
PROPERTY OF GENERAL FILTER COMPANY

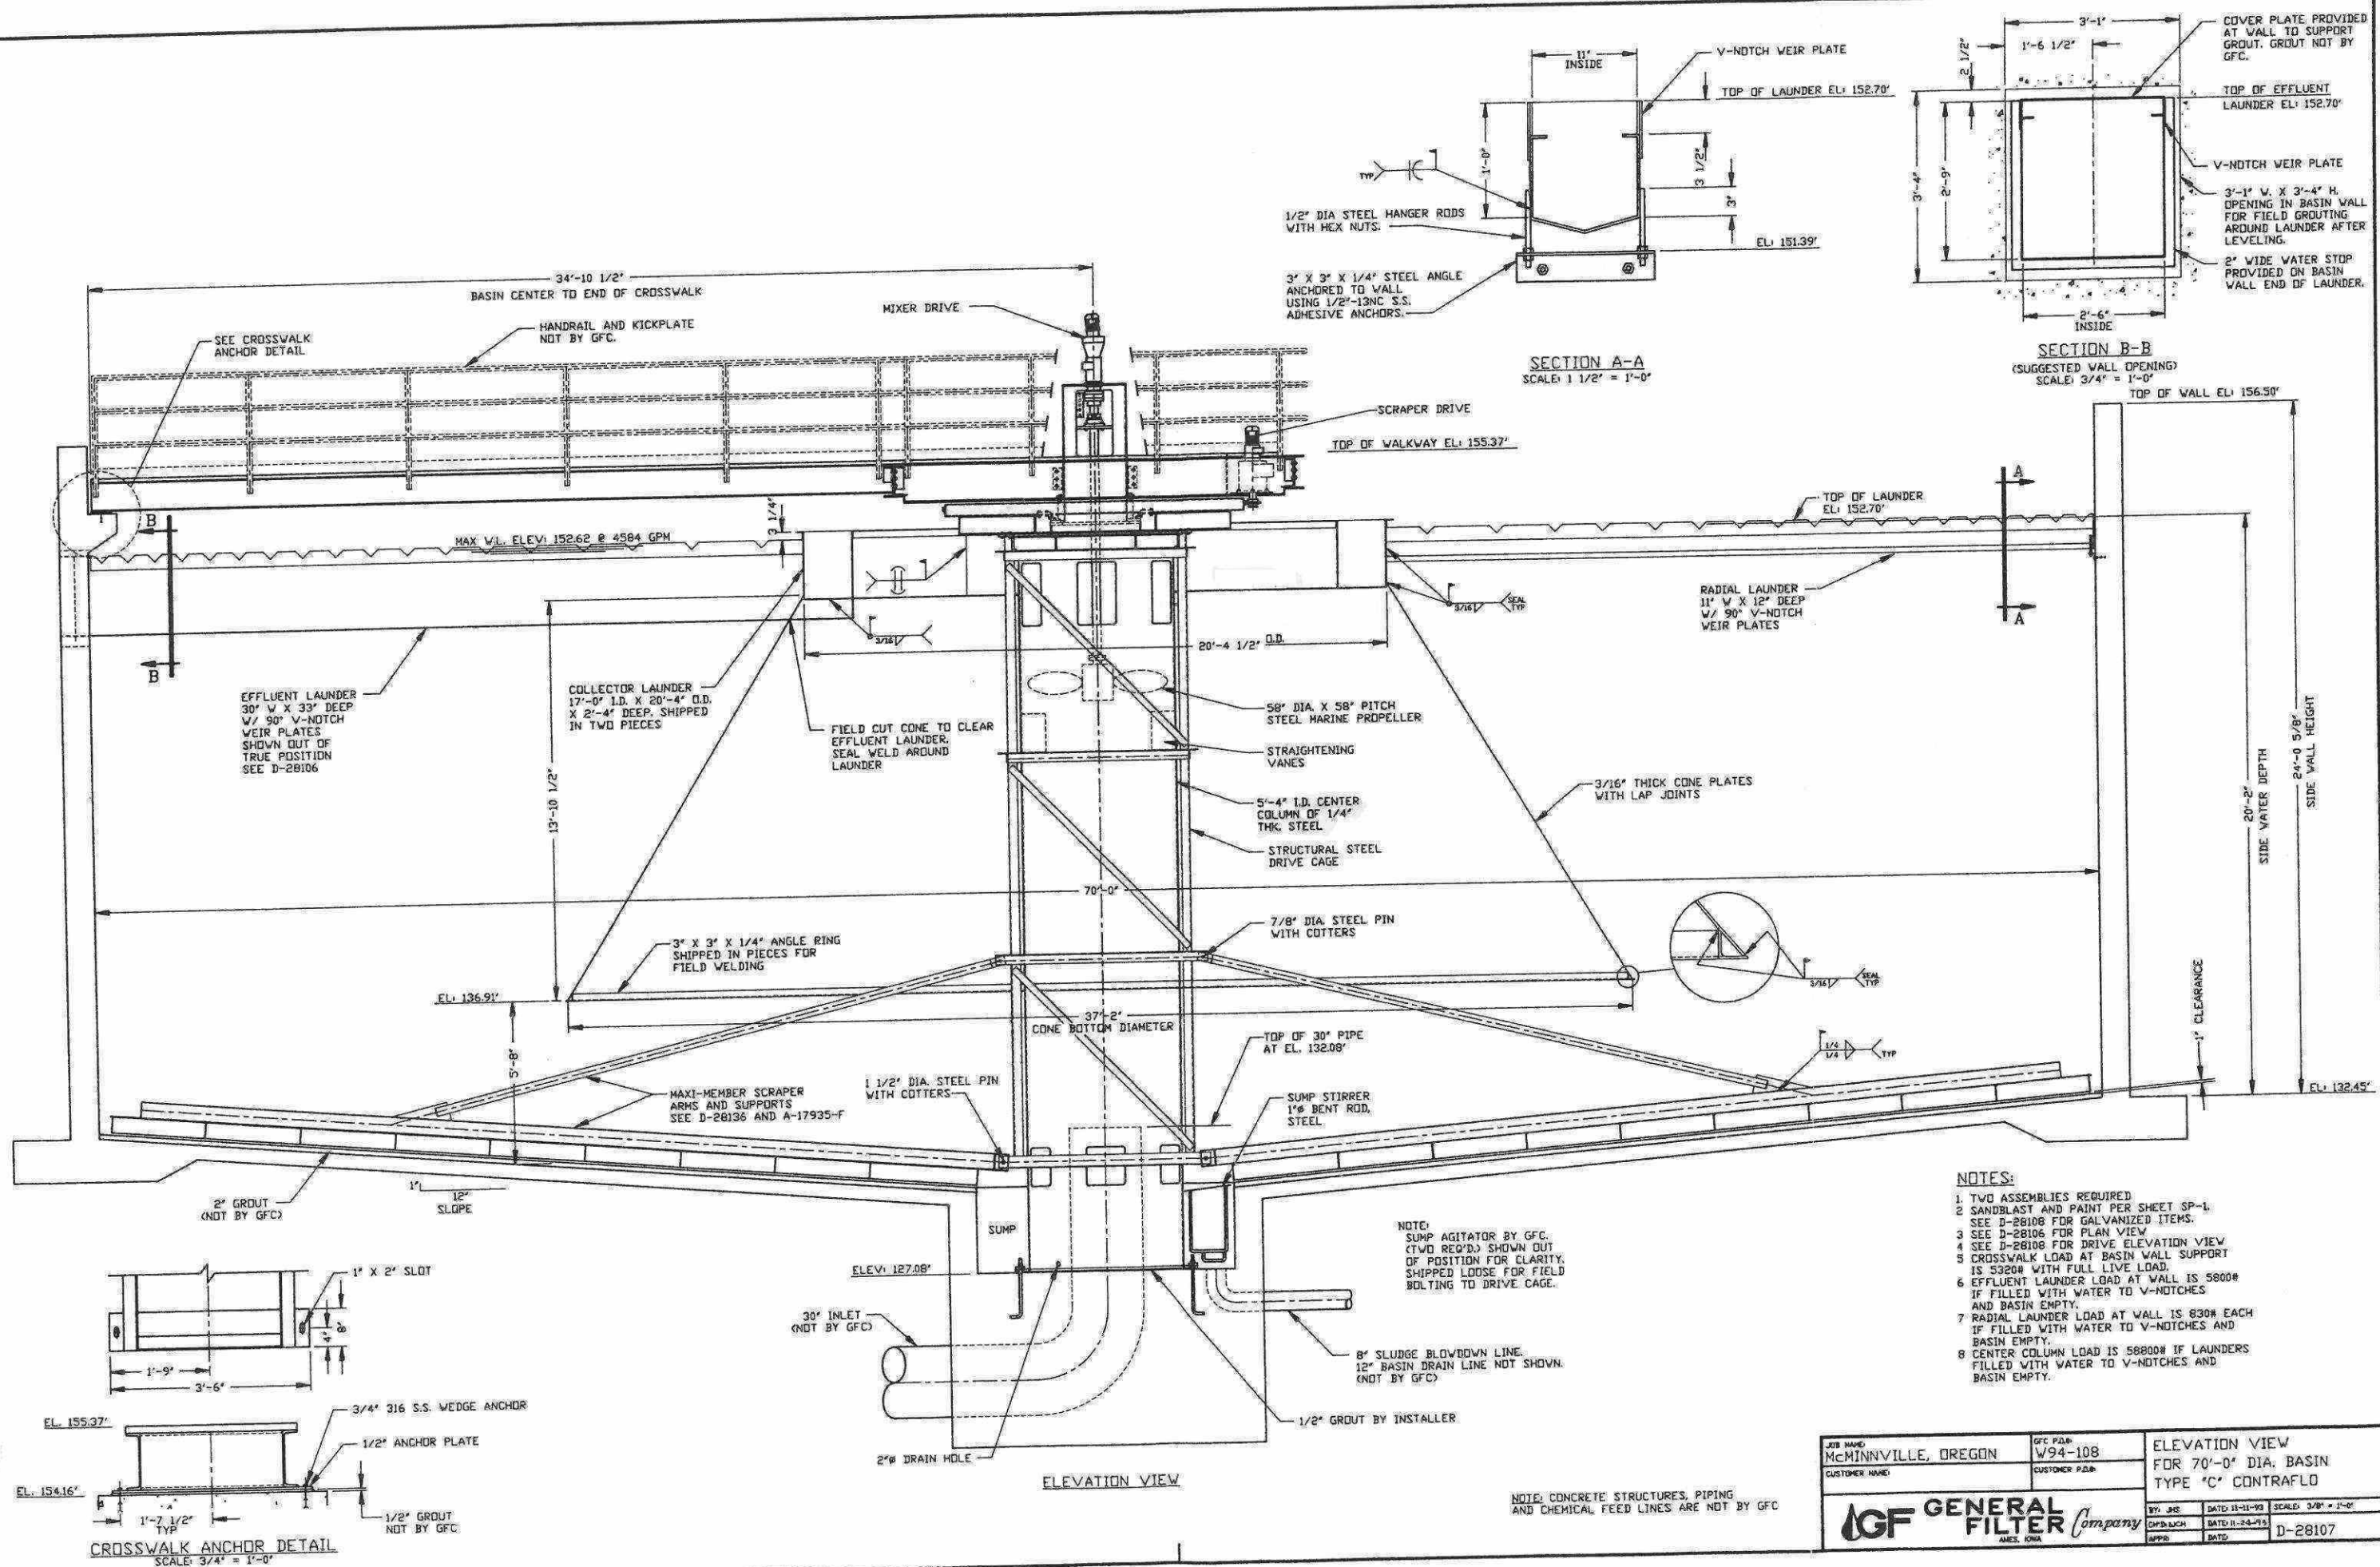

JOB NAME McMINNVILLE, OREGON	GFC P&ID W94-108	ELEVATION VIEW FOR 70'-0" DIA. BASIN TYPE 'C' CONTRAFLO
CUSTOMER NAME	CUSTOMER P&ID	
BY: JIS	DATE: 11-11-93	SCALE: 3/8" = 1'-0"
CHKD BY: JIS	DATE: 11-24-93	
APPD: JIS	DATE:	D-28107